

PROJECT TITLE
TCC/SHORE TRANSIT BUS MAINTENANCE FACILITY - PHASE II

31855 TRI-COUNTY WAY
 SALISBURY, MD. 21804




ISSUED FOR BIDDING
 DATE: 01/05/12

SHEET TITLE
DOMESTIC PLUMBING PLANS

Mark	Date	Description
△	12.21.2001	FIRE SPRINKLER ADDITION
△	11.4.2011	CODE REVIEW COMMENTS

Project Number	2009145.00
Date	01/05/12
Scale	1/8" = 1'-0"
Drawn By	PLG
Checked By	DV

P200

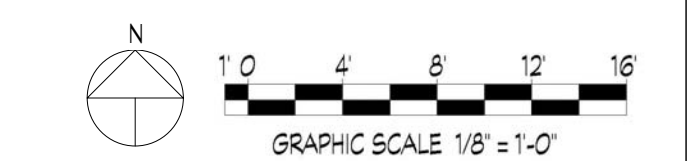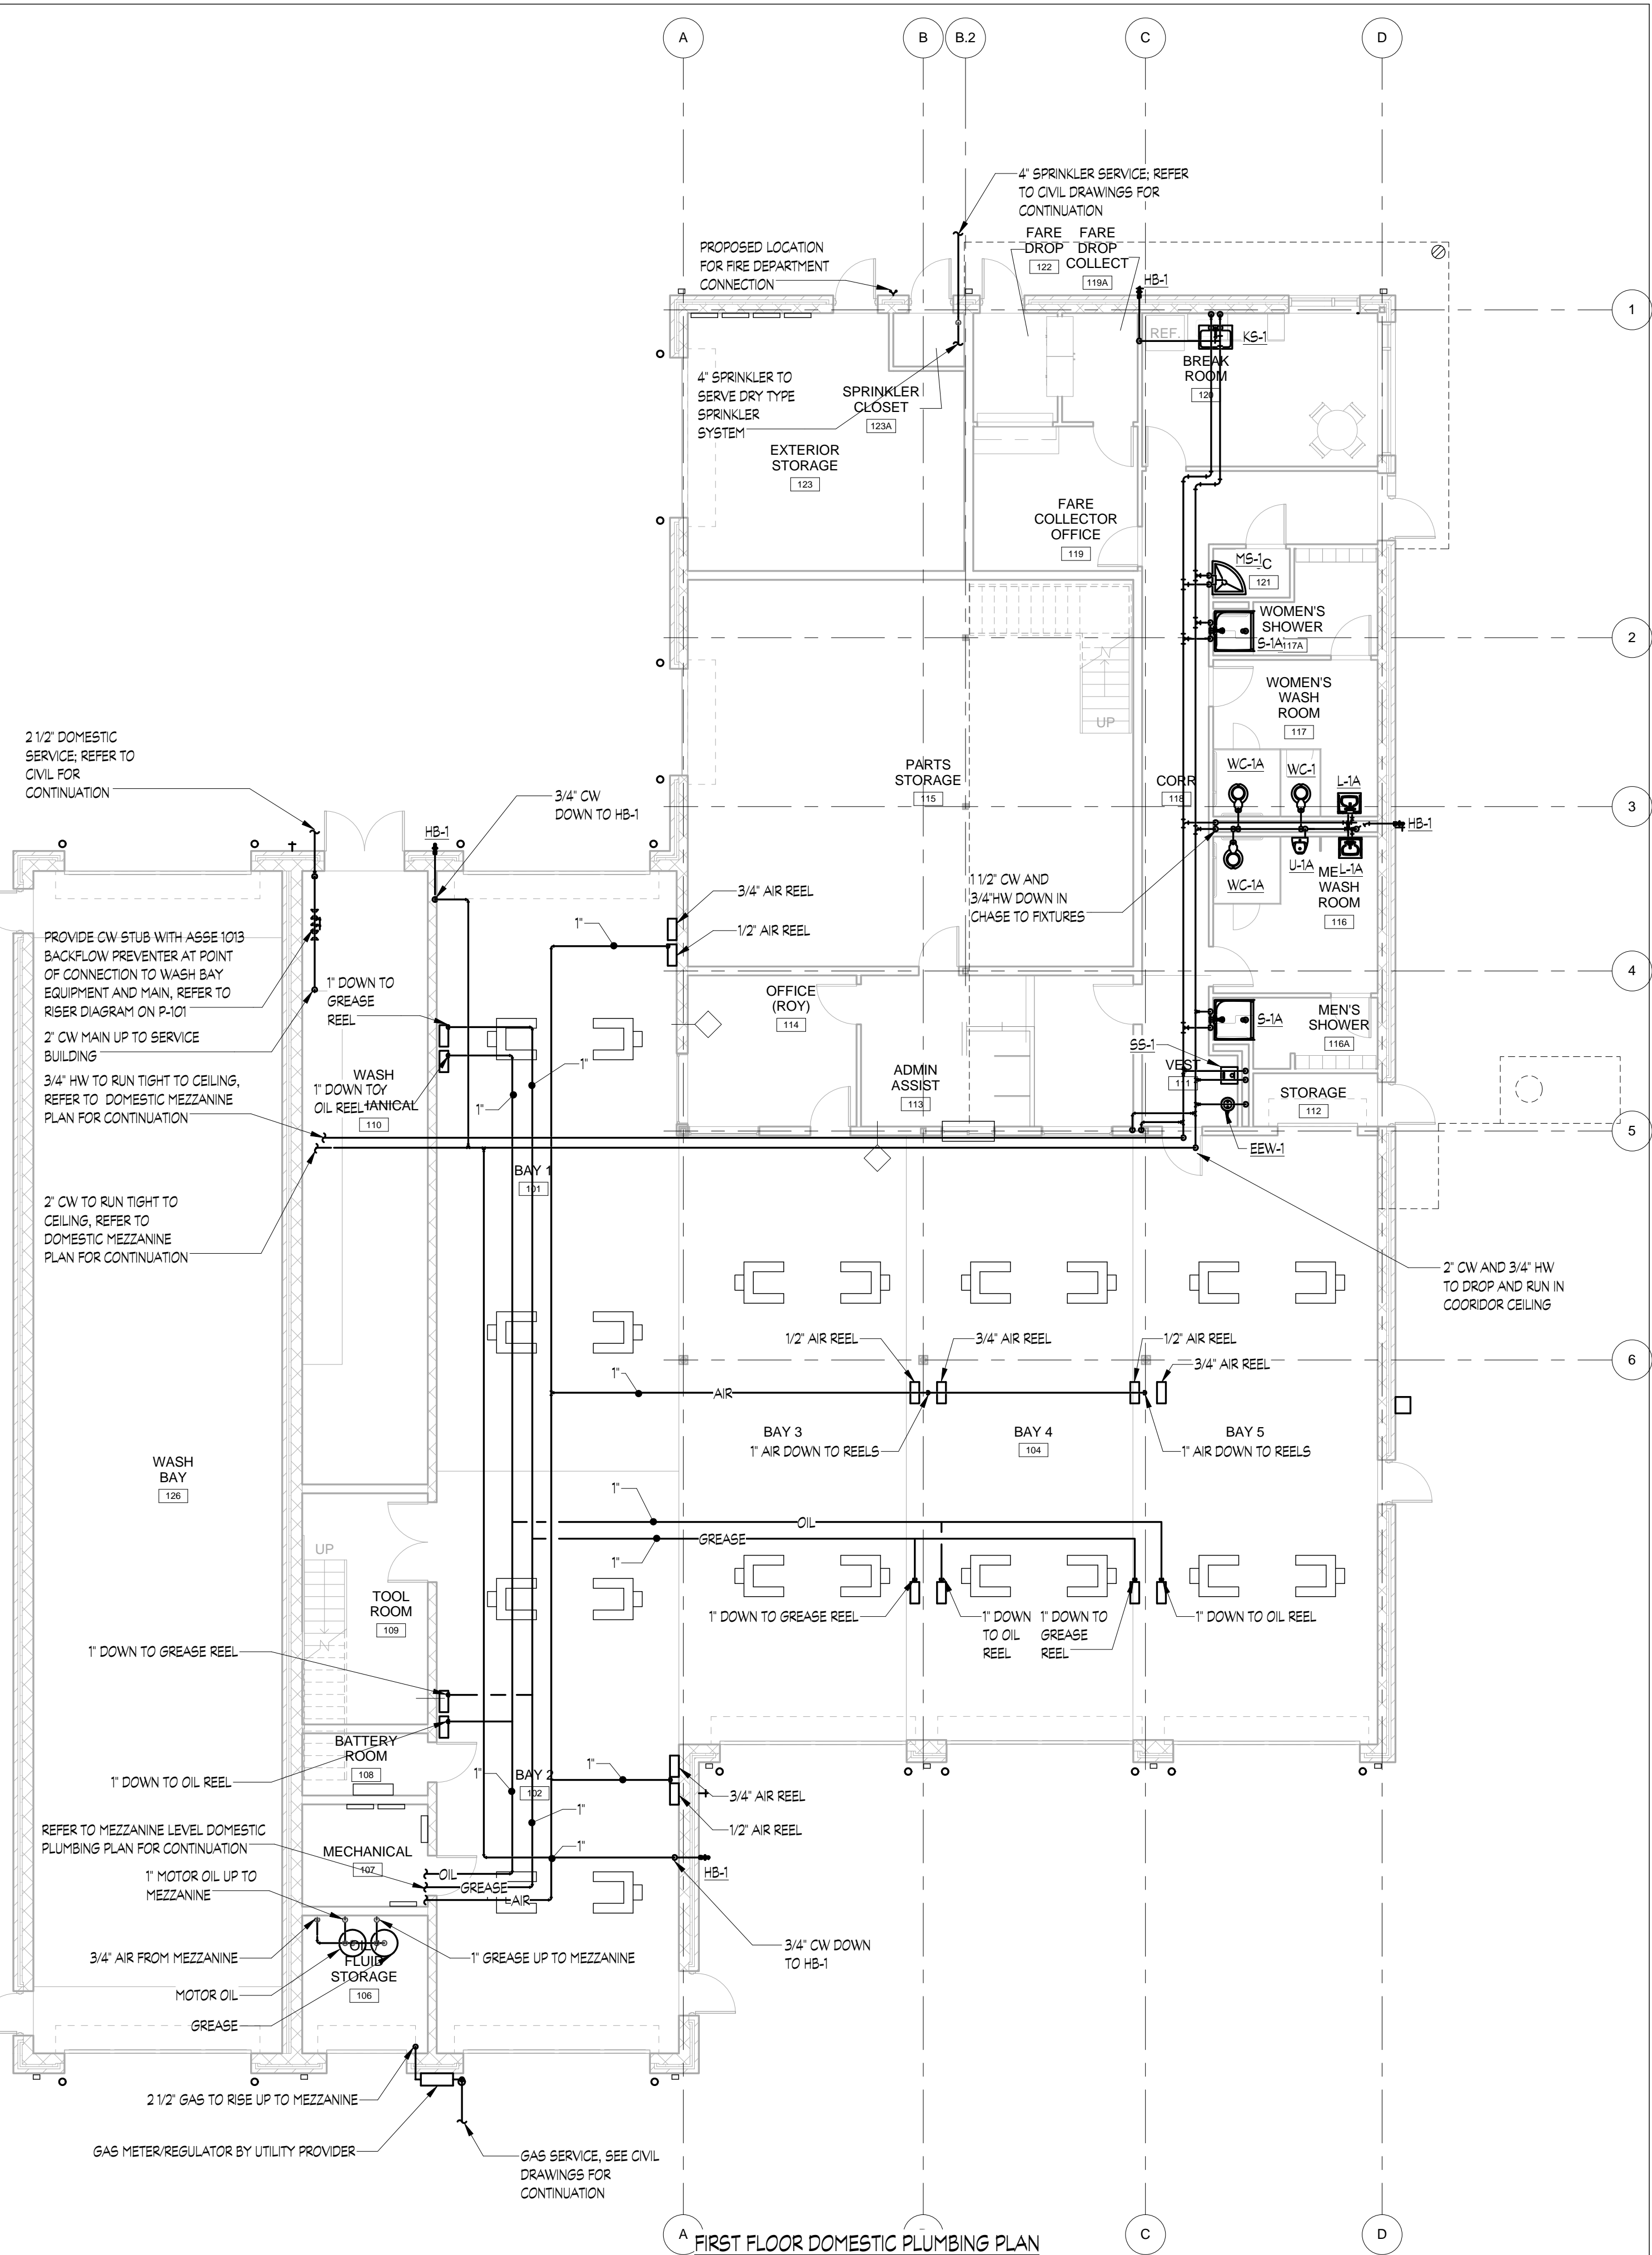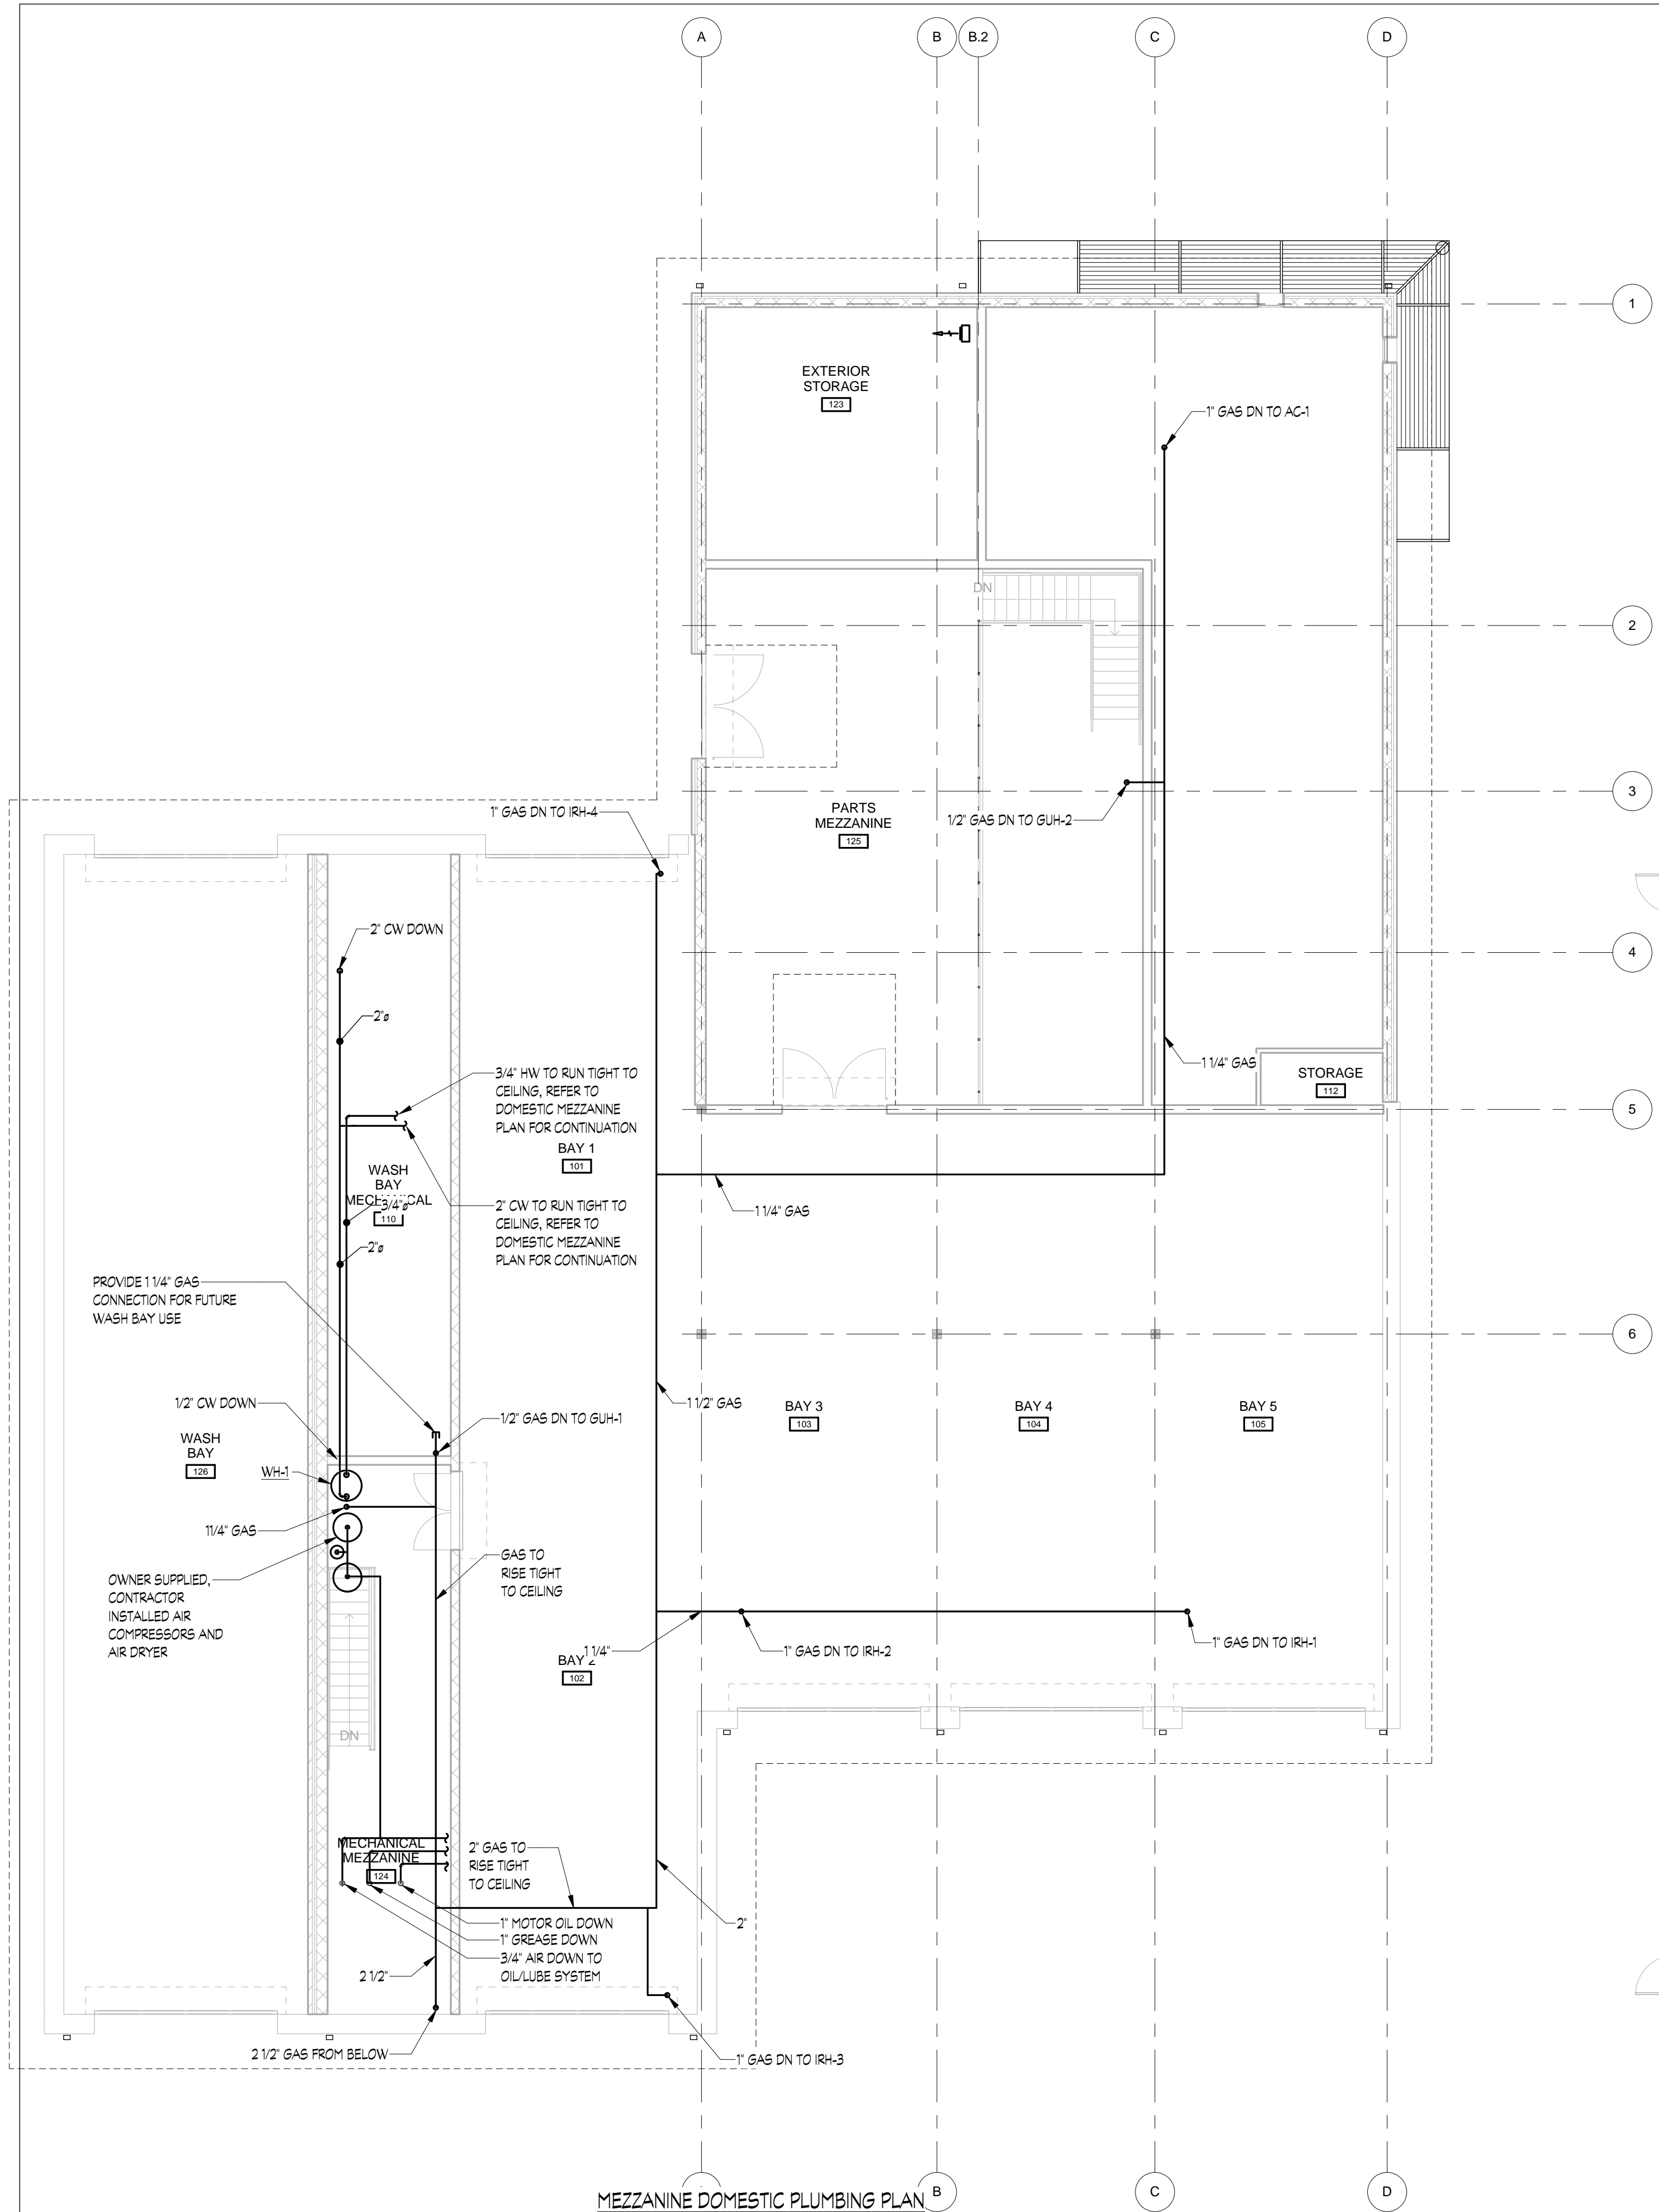

1/4/2012 2:12:29 PM \\salisbury\allen\shariff\com\today\jobs\101031029\TCC Bus Facility\Activel\1031029.MEP.rvt