


SPECIFIC NOTES: (APPLY TO DRAWING M200 WHERE INDICATED)

- ① 40x18 SA AND 50x20 RA UP TO BAG-1, TRANSITION UP TO UNIT WITH FLEXIBLE CONNECTION. PROVIDE 1" SOUND LINING FOR FIRST 10' OF RA DUCT.
- ② OED W/ BIRDSCREEN.

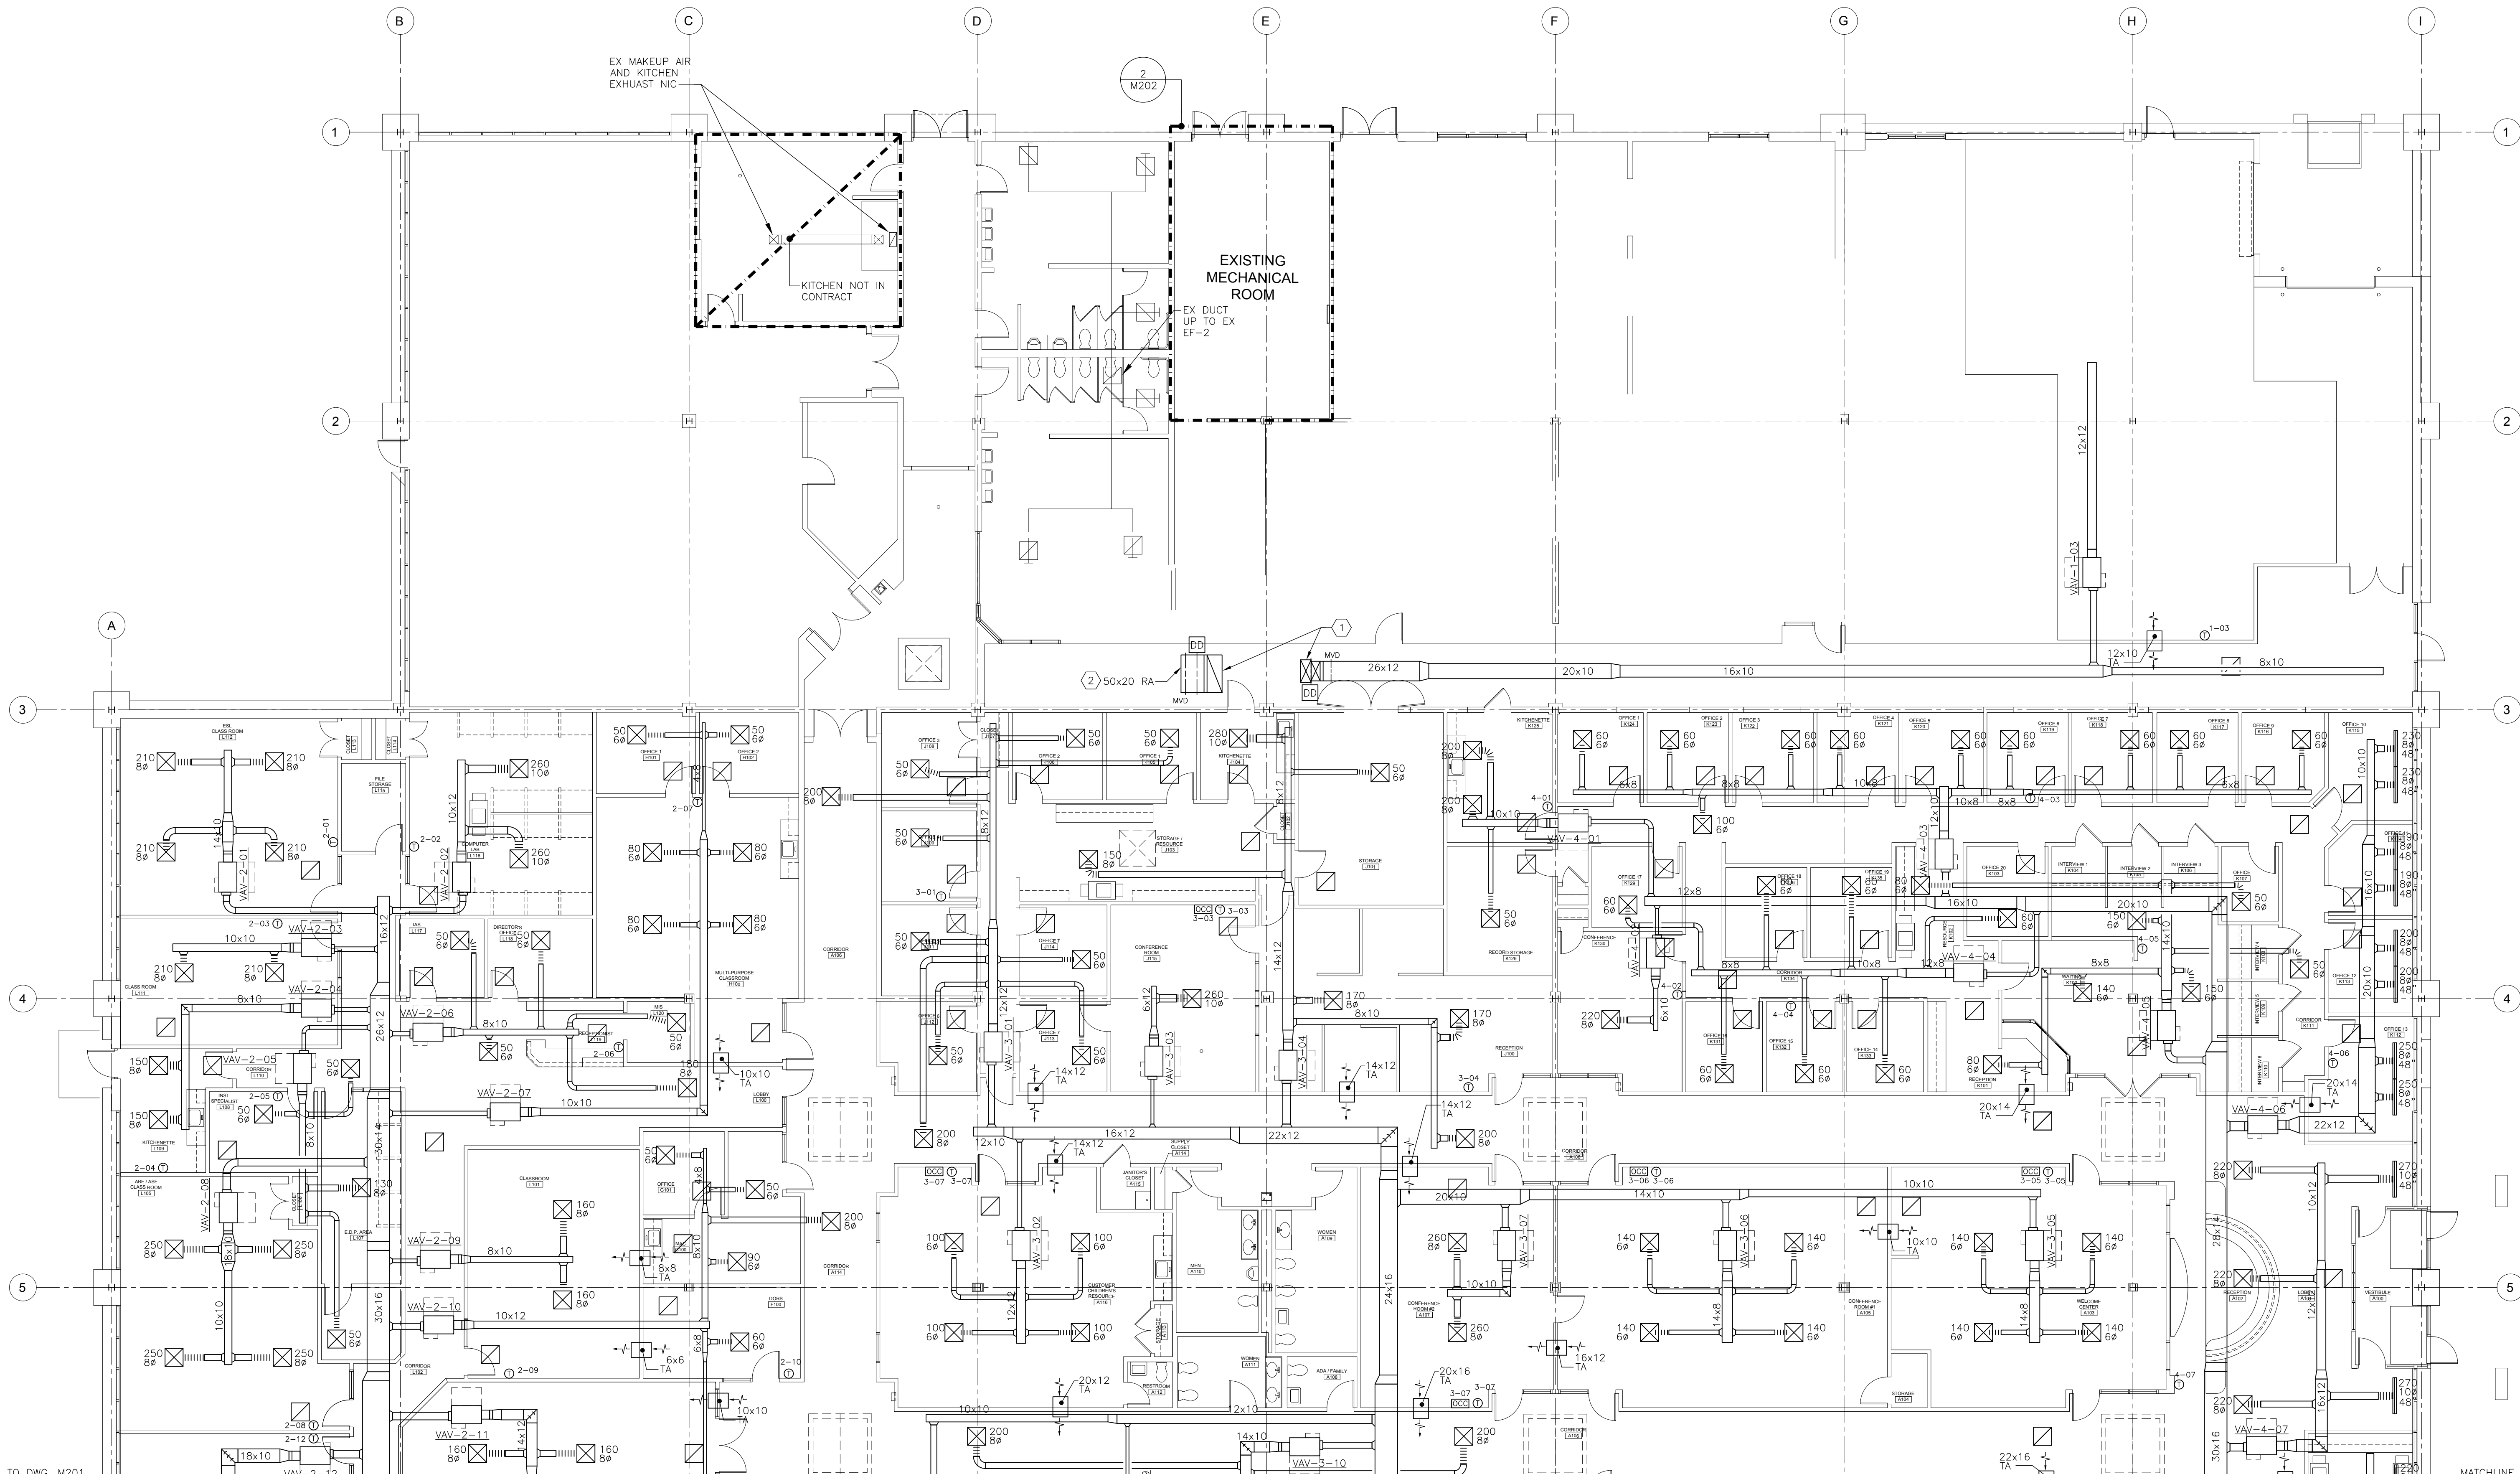


FIRST FLOOR PLAN - MECHANICAL DUCTWORK - NEW WORK
 SCALE: 1/8" = 1'-0"

GRILLE, REGISTER AND DIFFUSER SCHEDULE

SYMBOL	MANUFACTURER	MODEL	SERVICE	MODULE (L" x W")	FINISH	MOUNTING	N.C.	NOTES
	PRICE	SCD	SUPPLY DIFFUSER	24 X 24	WHITE POWDER COAT	CEILING	<30	1
	PRICE	PDDR	RETURN DIFFUSER	24 X 24	WHITE POWDER COAT	CEILING	<30	2
	PRICE	TBD2100	T-BAR DIFFUSER 2-SLOT	SEE DWGS	WHITE POWDER COAT	CEILING	<30	1,3
	TATE	PERF1250	AIR FLOW PANEL	24 X 24	EPOXY PAINT FINISH	FLOOR	<30	4
	PRICE	620	SUPPLY GRILLE	SEE DWGS	WHITE POWDER COAT	WALL	<30	-

- NOTES:**
- 1. NECK SIZE SHALL BE SAME AS BRANCH DUCT SIZE UNLESS OTHERWISE NOTED.
 - 2. PROVIDE FOR CEILING PLENUM RETURN.
 - 3. MODULE LENGTH NOTED ON DRAWINGS.
 - 4. COLOR TO BE SELECTED BY ARCHITECT/OWNER.

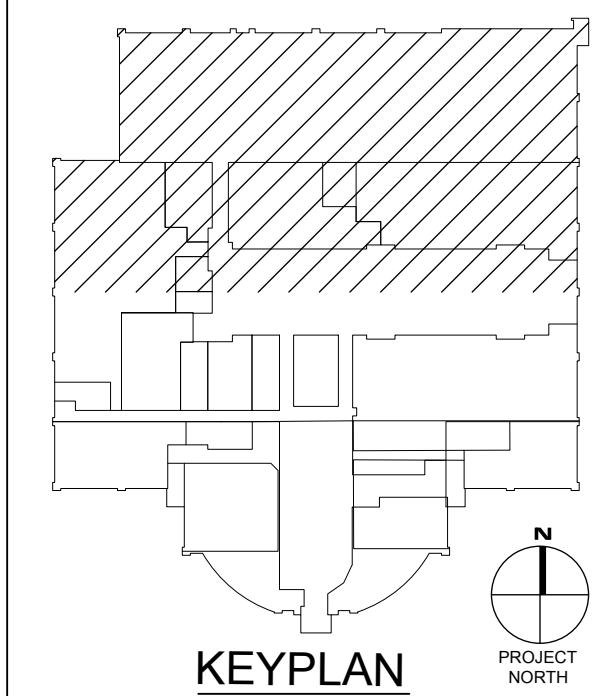

NO.	DATE	REMARKS	NO.	DATE	REMARKS

Professional Certification:
 These documents were prepared or approved by a duly licensed professional engineer under the laws of the State of Maryland. License No. 69981, Expiration Date: 2012-08-15.

IOTT
 ARCHITECTURE
 ENGINEERING
 INCORPORATED
 SUITE 100
 310 HAMMOND ST. SALISBURY, MARYLAND
 (410) 749-7229 • FAX (410) 749-9000

TRI - COUNTY COUNCIL
REGIONAL CENTER
ROUTE 50 EAST
SALISBURY, MARYLAND
 FIRST FLOOR PLAN - MECHANICAL - NEW WORK

PRINT DATE: 11/01/10
 SPA PROJ. NO.: 2009 084
 DESIGN BY: MWTC
 DRAWN BY: TC/MW
 SCALE: AS NOTED
 STAGE: ISSUED FOR BIDS
 DWG. FILE: 09264R205-202

M 200
 SHEET: 8 OF 28
 ISSUED DATE: 11/01/10