


GRILLE, REGISTER AND DIFFUSER SCHEDULE								
SYMBOL	MANUFACTURER	MODEL	SERVICE	MODULE (L" x W")	FINISH	MOUNTING	N.C.	NOTES
	PRICE	SCD	SUPPLY DIFFUSER	24 X 24	WHITE POWDER COAT	CEILING	<30	1
	PRICE	PDDR	RETURN DIFFUSER	24 X 24	WHITE POWDER COAT	CEILING	<30	2
	PRICE	TBD2100	T-BAR DIFFUSER 2-SLOT	SEE DWGS	WHITE POWDER COAT	CEILING	<30	1,3
	TATE	PERF125G	AIR FLOW PANEL	24 X 24	EPOXY PAINT FINISH	FLOOR	<30	4
	PRICE	620	SUPPLY GRILLE	SEE DWGS	WHITE POWDER COAT	WALL	<30	-


**NOTES:**  
 1. NECK SIZE SHALL BE SAME AS BRANCH DUCT SIZE UNLESS OTHERWISE NOTED.  
 2. PROVIDE FOR CEILING PLENUM RETURN.  
 3. MODULE LENGTH NOTED ON DRAWINGS.  
 4. COLOR TO BE SELECTED BY ARCHITECT/OWNER.

**SPECIFIC NOTES: (APPLY TO DRAWING M201 WHERE INDICATED)**

- 50x18 SA AND 60x20 RA UP TO BAC-2, TRANSITION UP TO UNIT WITH FLEXIBLE CONNECTION. PROVIDE 1" SOUND LINING FOR FIRST 10' OF RA DUCT
- DED W/ BIRDSCREEN.
- 30x16 SA AND 34x20 RA UP TO BAC-3, TRANSITION UP TO UNIT WITH FLEXIBLE CONNECTION. PROVIDE 1" SOUND LINING FOR FIRST 10' OF RA DUCT
- 50x20 SA AND 70x20 RA UP TO BAC-4, TRANSITION UP TO UNIT WITH FLEXIBLE CONNECTION. PROVIDE 1" SOUND LINING FOR FIRST 10' OF RA DUCT
- TRANSITION AND MAKE CONNECTION TO EXISTING SUPPLY AND RETURN DUCTWORK IN EXISTING CHASE.

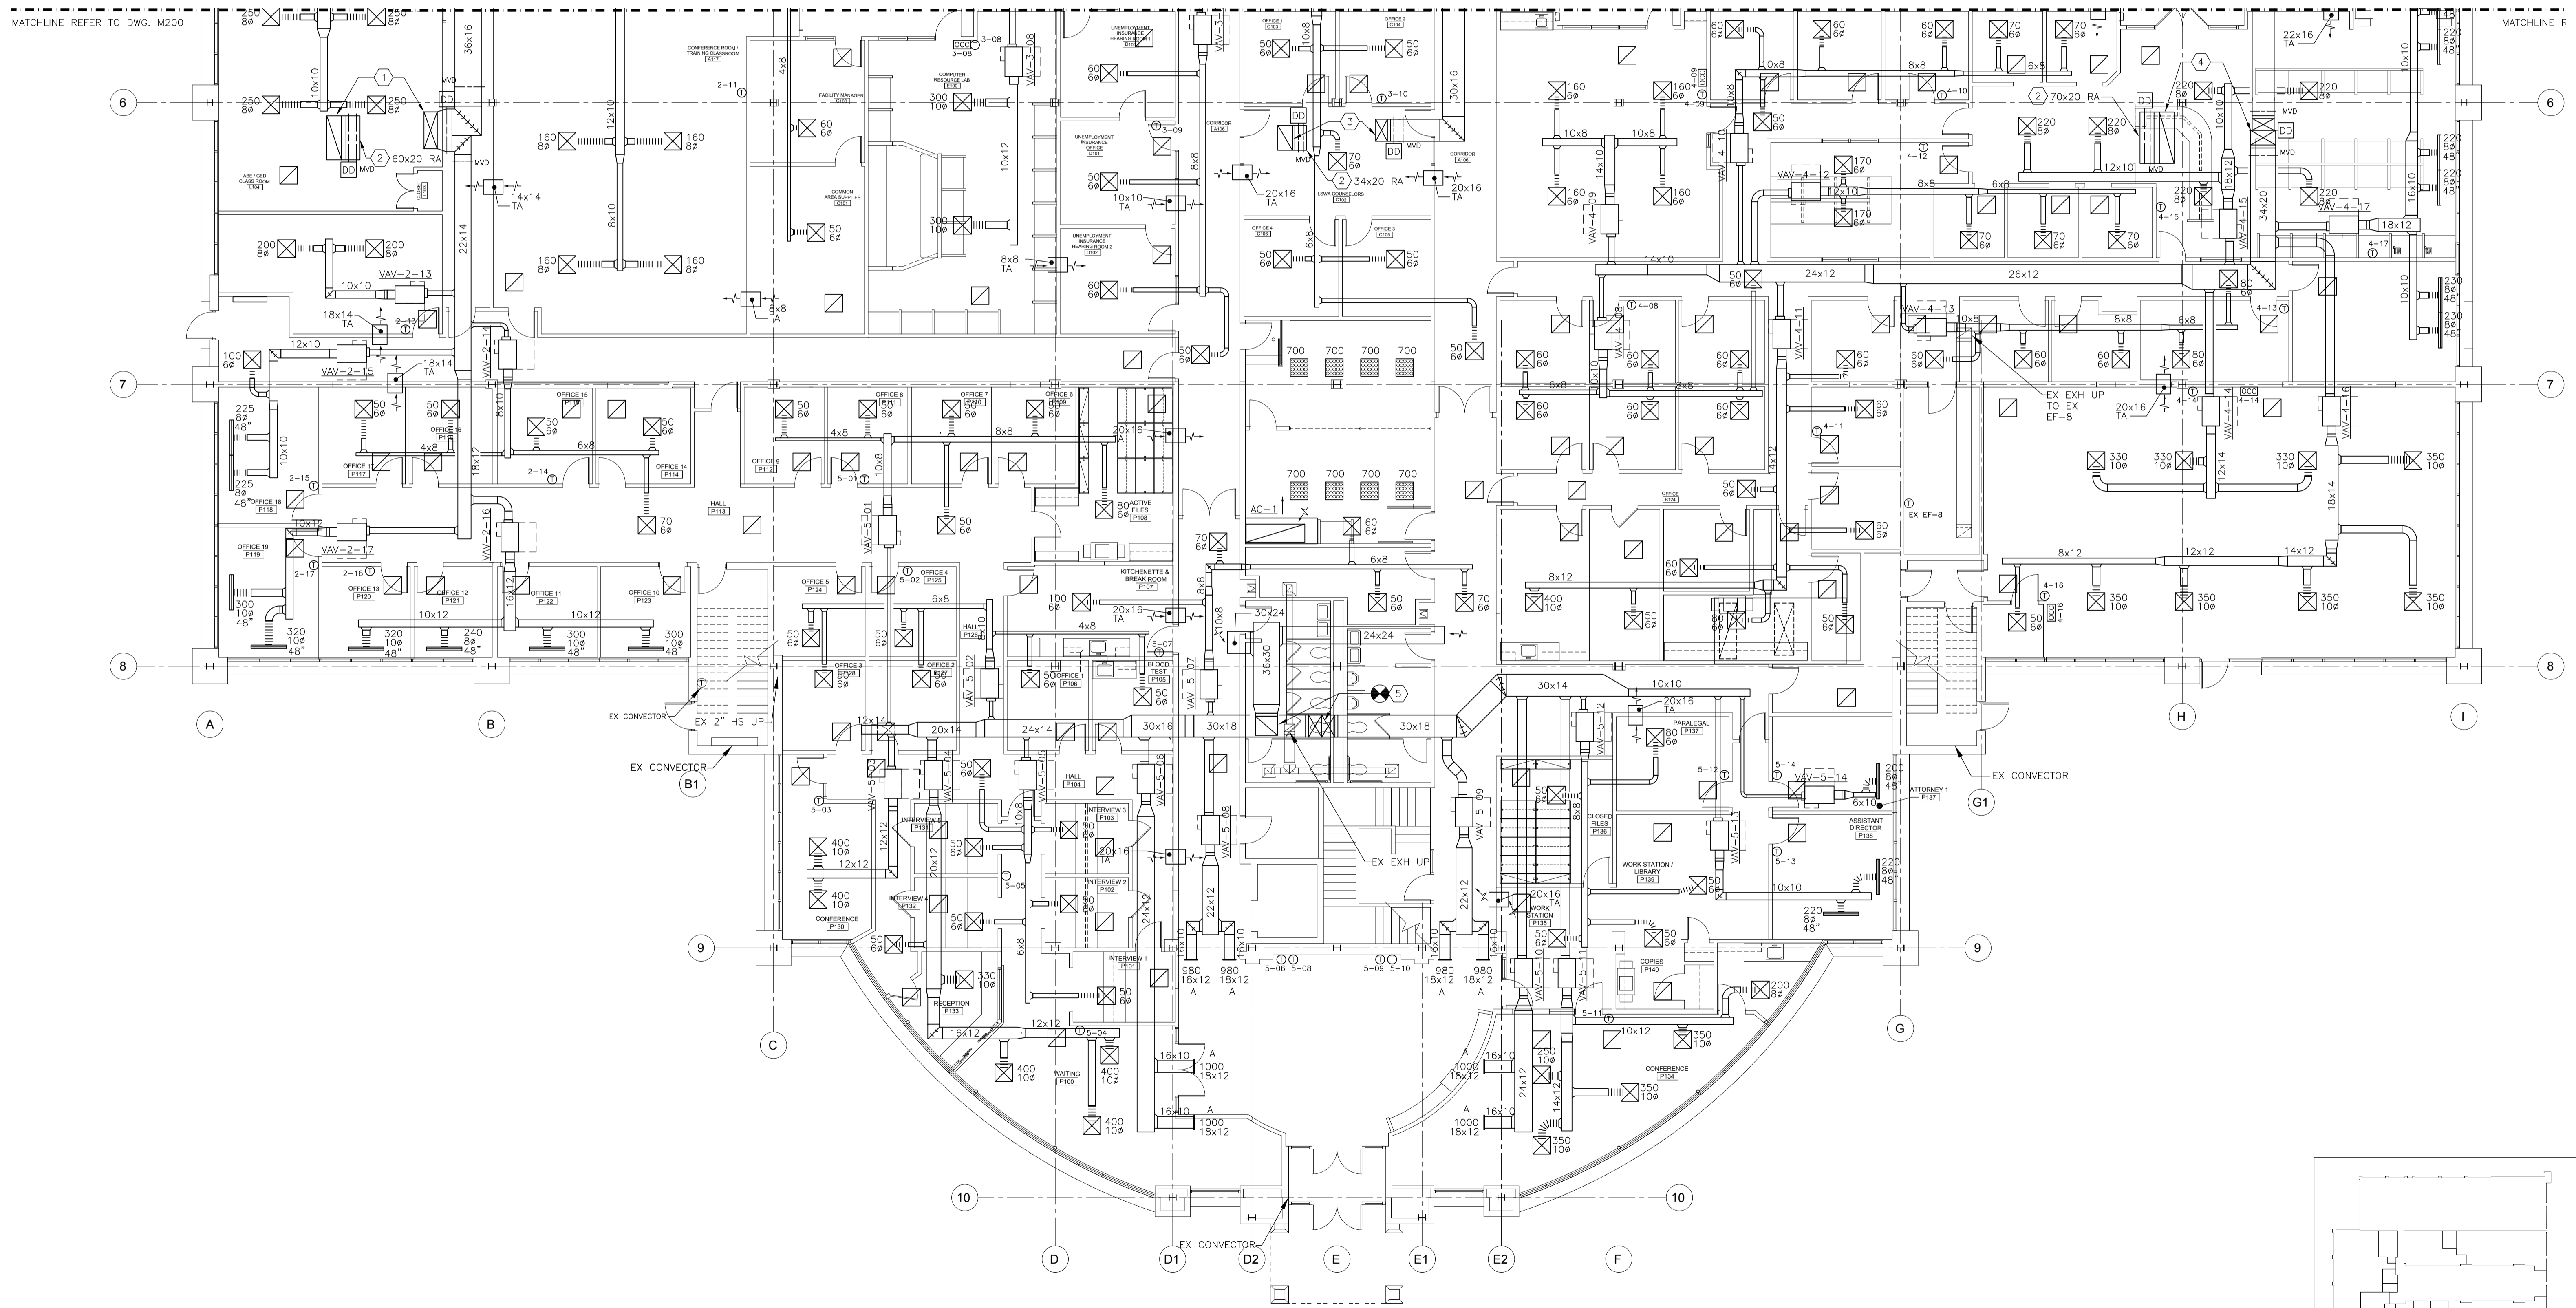

**FIRST FLOOR PLAN - MECHANICAL DUCTWORK - NEW WORK**  
 SCALE: 1/8" = 1'-0"

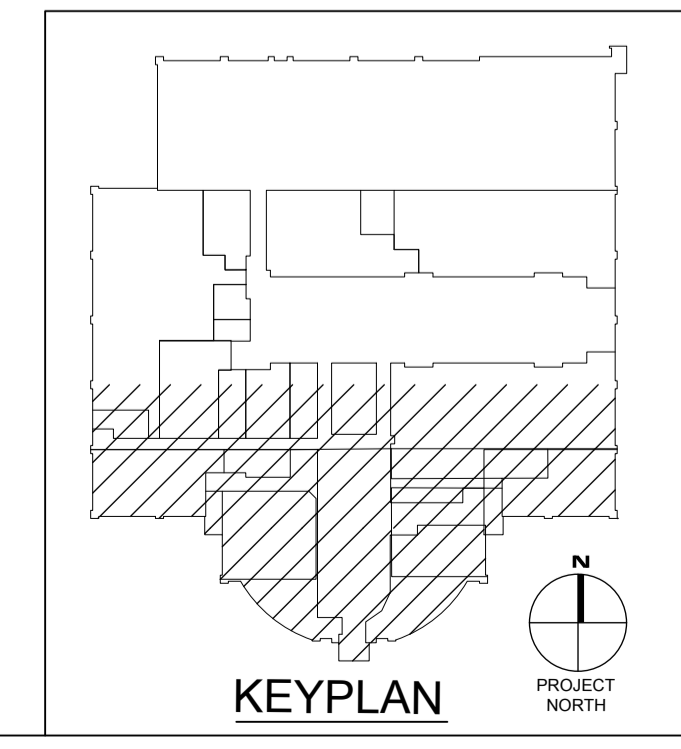

REVISIONS		REMARKS
NO.	DATE	

Professional Certification:  
 these documents were  
 prepared or approved by  
 a duly licensed professional  
 engineer under the laws  
 of the State of Maryland,  
 License No. 69981,  
 Expiration Date:  
 2012-08-15.

**IOTT**  
 ARCHITECTURE  
 ENGINEERING  
 INCORPORATED  
 SUITE 100 SALISBURY, MARYLAND  
 310 HAMMOND ST. (410) 746-2229 • FAX (410) 746-9000

**TRI - COUNTY COUNCIL  
 REGIONAL CENTER  
 ROUTE 50 EAST  
 SALISBURY, MARYLAND**  
 FIRST FLOOR PLAN - MECHANICAL - NEW WORK

PRINT DATE: 11/01/10  
 SPA PROJ. NO.: 2009 084  
 DESIGN BY: MWTC  
 DRAWN BY: TC/MW  
 SCALE: AS NOTED  
 STAGE: ISSUED FOR BIDS  
 DWG. FILE: 09264R205-202

**M 201**  
 SHEET: 9 OF 26  
 ISSUED DATE: 11/01/10