


SPECIFIC NOTES (APPLY TO DRAWING M204 WHERE INDICATED):


- ① AIR TERMINAL UNIT HEATING COIL VALVING ASSEMBLY, REFER TO DETAIL-7 ON DWG. M500 FOR ADDITIONAL INFORMATION (TYP. ALL TERMINAL UNITS).
- ② EXISTING CONVERTOR HEATING COIL VALVING ASSEMBLY, REFER TO DETAIL-12 ON DWG. M500 FOR ADDITIONAL INFORMATION.

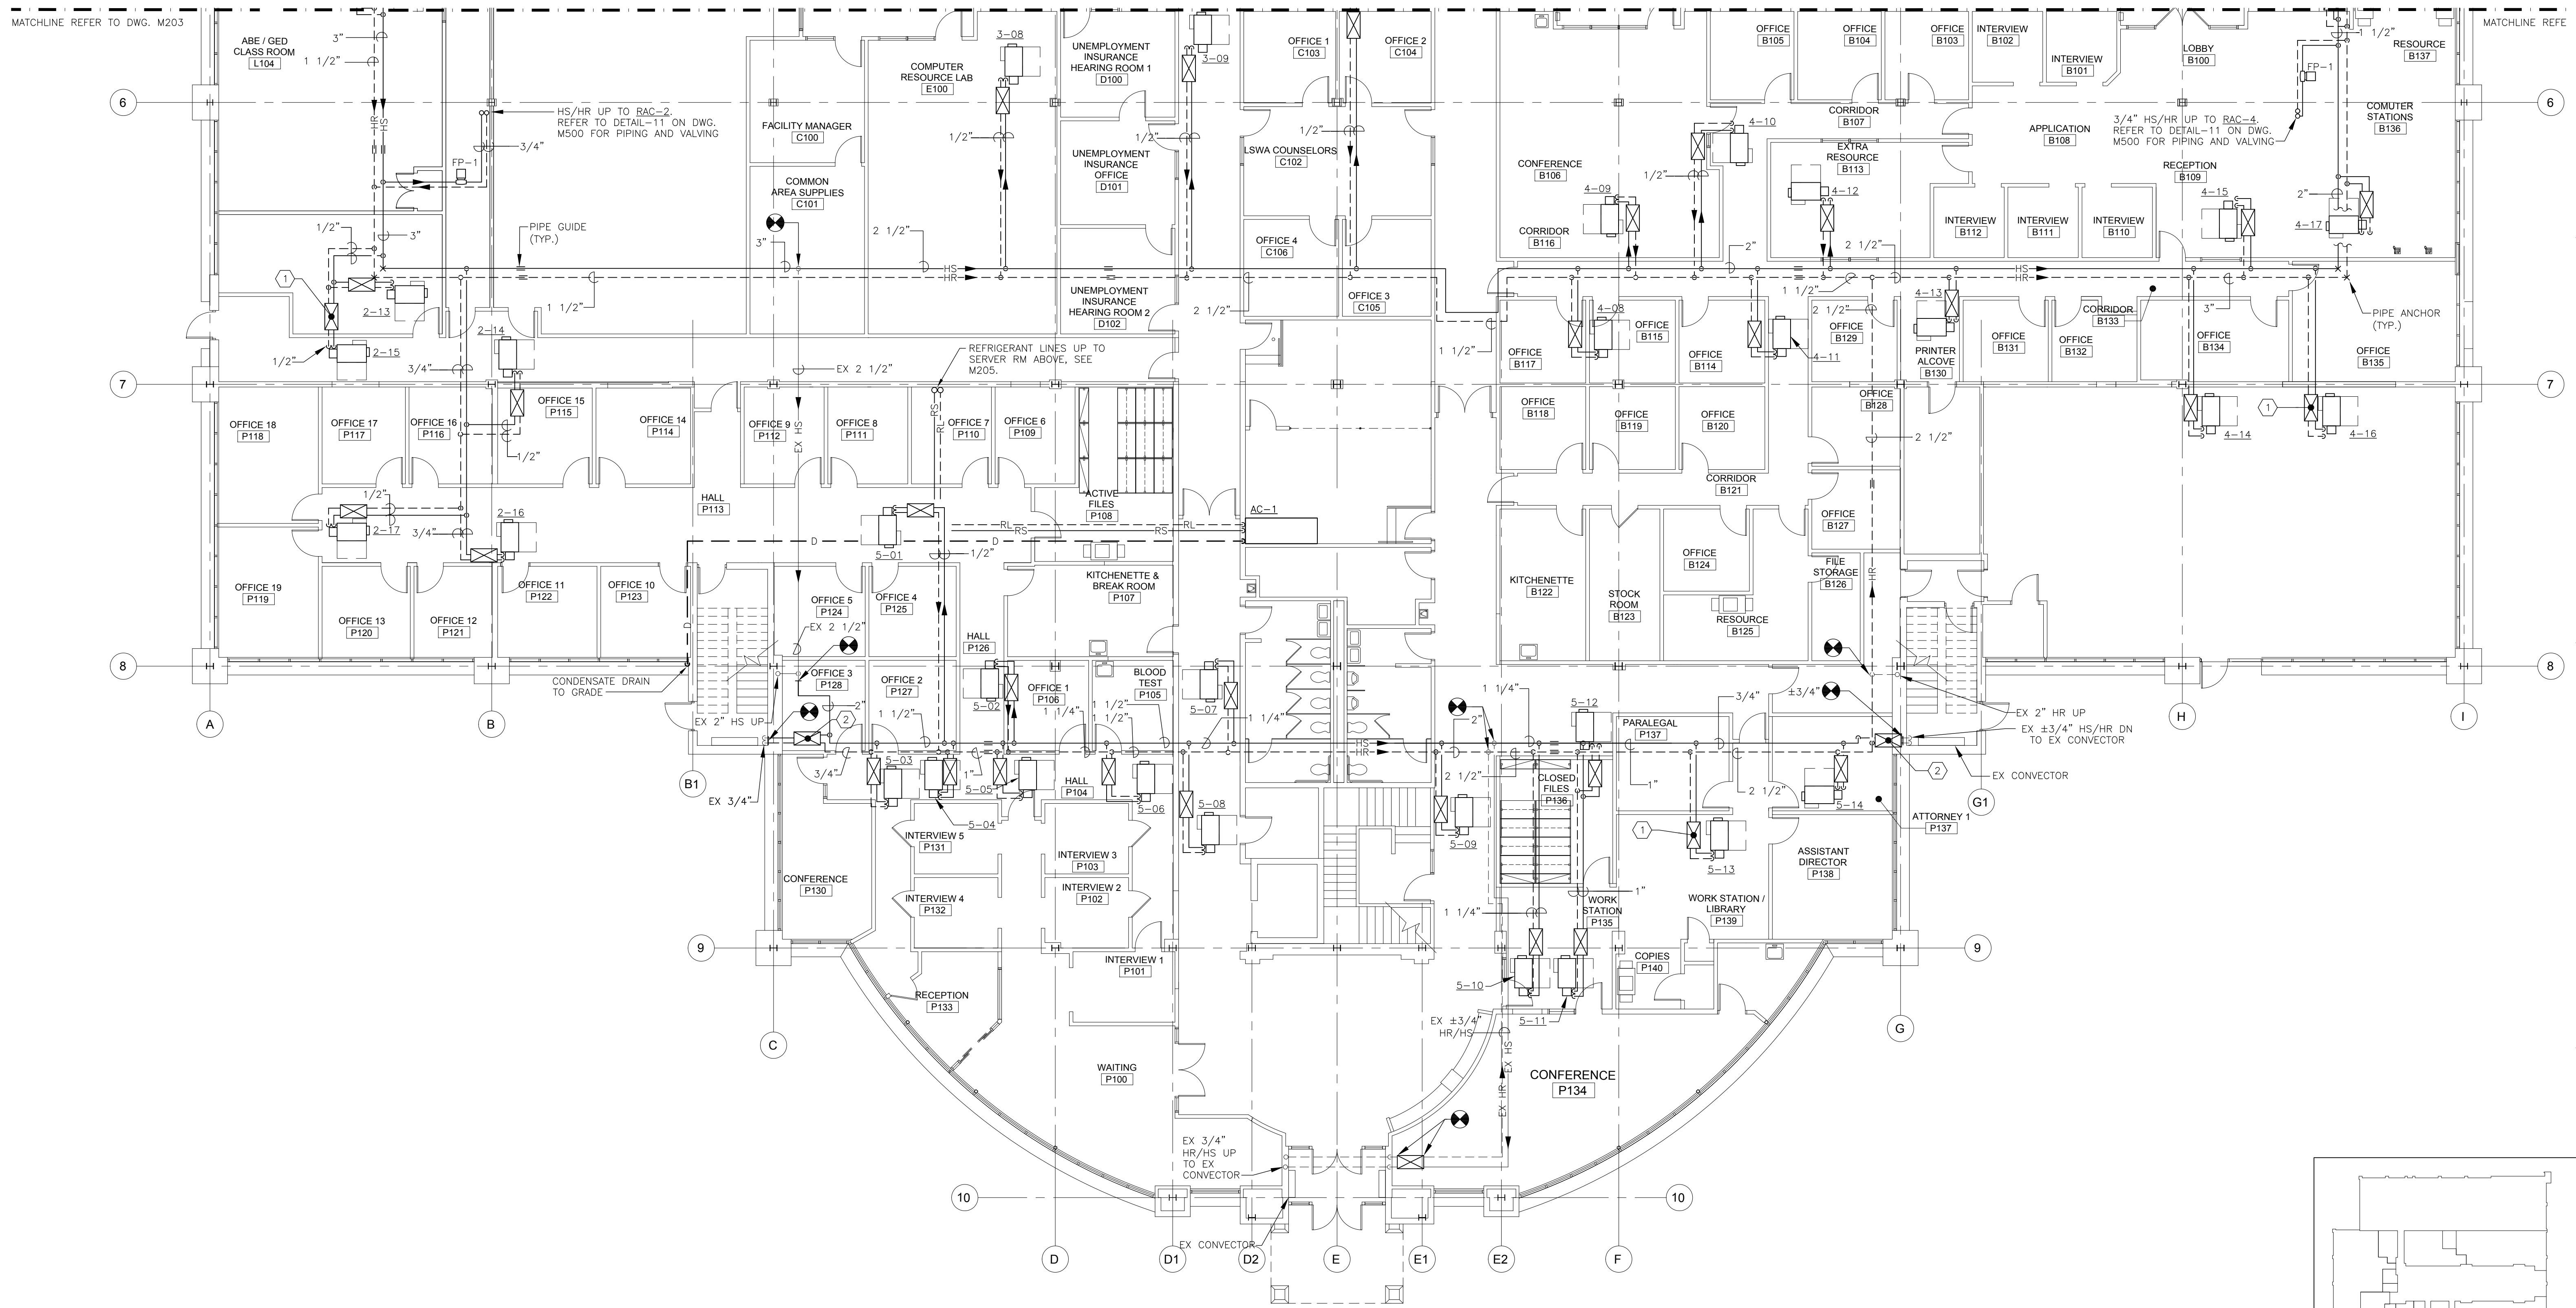

FIRST FLOOR PLAN - MECHANICAL PIPING - NEW WORK

SCALE: 1/8" = 1'-0"

NOTES:
1. FOR VAV BOX HS & HR BRANCH PIPE SIZES, REFER TO VAV TERMINAL UNIT SCHEDULE ON DWG. M001.

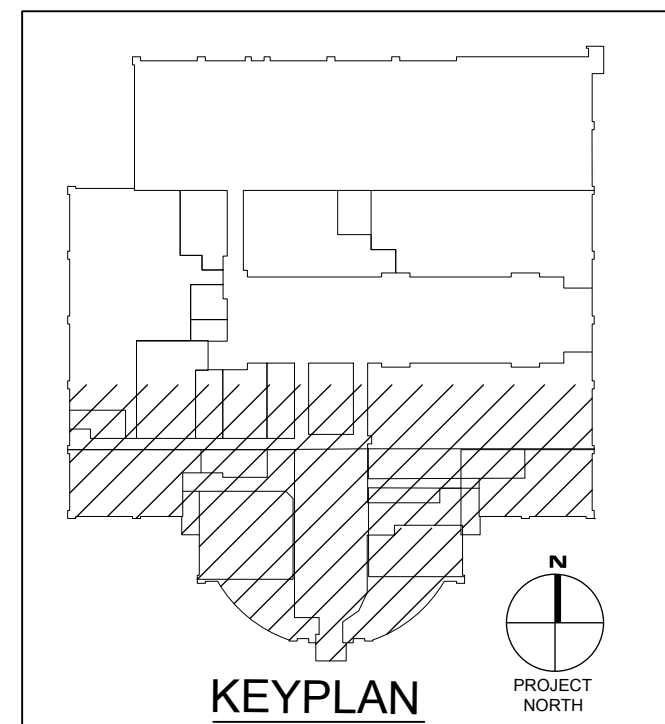

NO.	DATE	REMARKS	NO.	DATE	REMARKS

Professional Certification:
These documents were prepared or approved by a duly licensed professional engineer under the laws of the State of Maryland. License No. 69981. Expiration Date: 2012-08-15.

IOTT
ARCHITECTURE
ENGINEERING
INCORPORATED
SUITE 108 SALISBURY, MARYLAND
310 HAMMOND ST. (410) 748-7229 • FAX (410) 748-9000

TRI - COUNTY COUNCIL
REGIONAL CENTER
ROUTE 50 EAST
SALISBURY, MARYLAND
FIRST FLOOR PLAN - MECHANICAL - NEW WORK

PRINT DATE: 11/01/10
SPA PROJ. NO.: 2009.0284
DESIGN BY: MWTC
DRAWN BY: TC/MW
SCALE: AS NOTED
STAGE: ISSUED FOR BIDS
DWG. FILE: 0284M205.205

M 204
SHEET: 12 OF 26
ISSUED DATE: 11/01/10